
 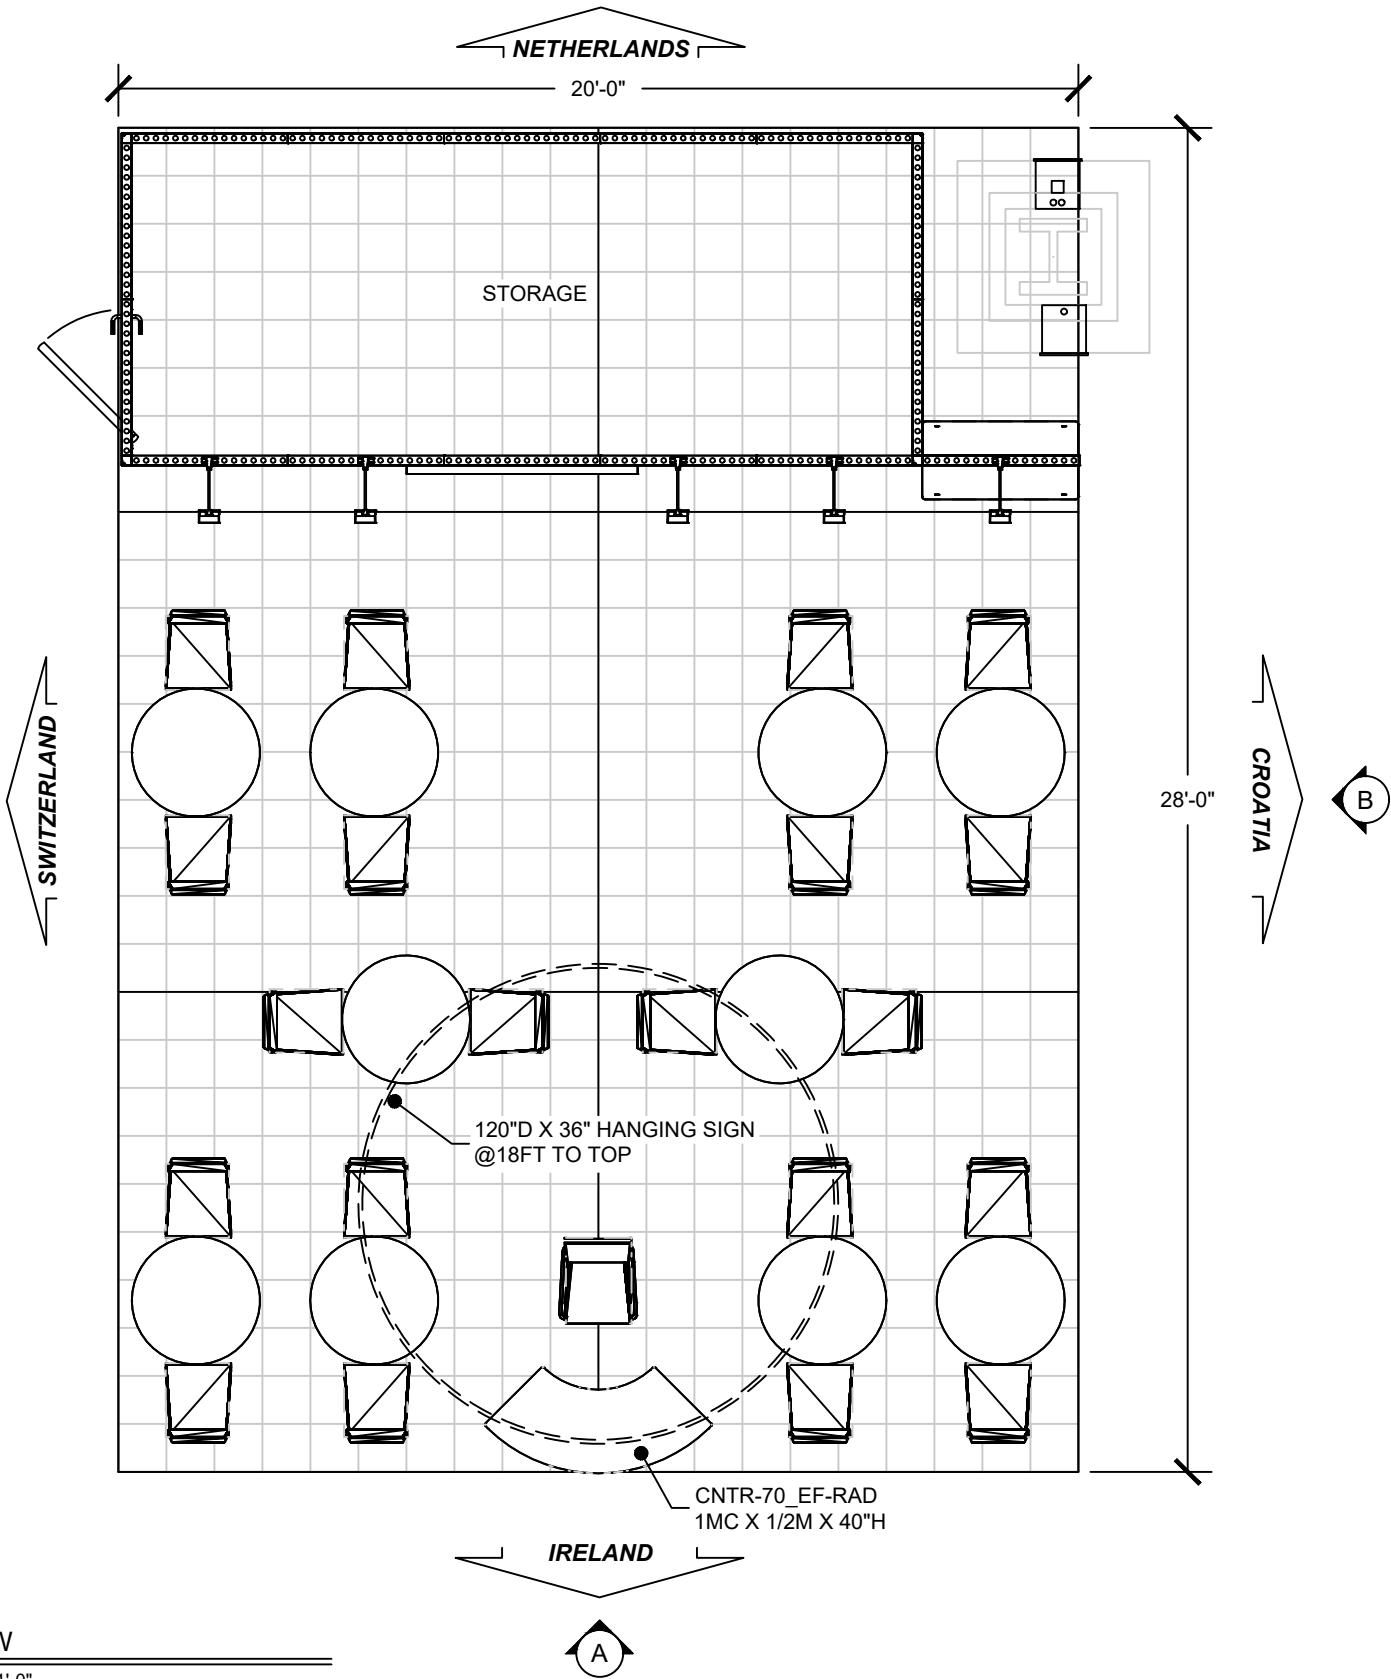
 





PLAN VIEW

SCALE: 1/4" = 1'-0"

GEM PART LEGEND									
									
P80 NOTCHED		P60	P50	P40	P30	H200	H45	H70	H50
									HINGE POST


 Part of the  GSP Collective	CLIENT: CZECH TOURISM SHOW: IMEX 2024 FACILITY: MANDALAY BAY CONVENTION CENTER CITY/STATE: LAS VEGAS, NV	SHOW DATE: 10/08/24 - 10/10/24 PROJ. #: 11-826658 BOOTH NO: E1623 BOOTH SIZE: 20' X 28' SHIP DATE: ----	TITLE: PLAN SCALE: AS NOTED DRAWING DATE: 06/06/24 DRAWN BY: K SCHULTZ DWG LOCATION: SHAREPOINT	SHEET #: 02 OF 10	DETAILING REVISION			
					No.	DATE	BY	DESCRIPTION
					CONTACT INFORMATION AE: GAYMARIE BARRY (708) 203-9714 AM: CLAUDIA LANCE (508) 408-2162			
					DWG LOCATION: SHAREPOINT			
					Copyright © 2024 Sprocket, a division of GSP. All rights Reserved. No Part of this document may be reproduced, stored in any retrieval system, or transmitted in any form or by any means, electronic, mechanical, photocopying, recording, or otherwise, without the express written consent of Sprocket, a division of GSP.			
					PM: ----			
					FILE NAME: SharePoint_Clients\Czech Tourism\2024\IMEX 2024_11-826658_17x30\Detailing\11-826658_Czech Tourism_IMEX 2024_v02.dwg			

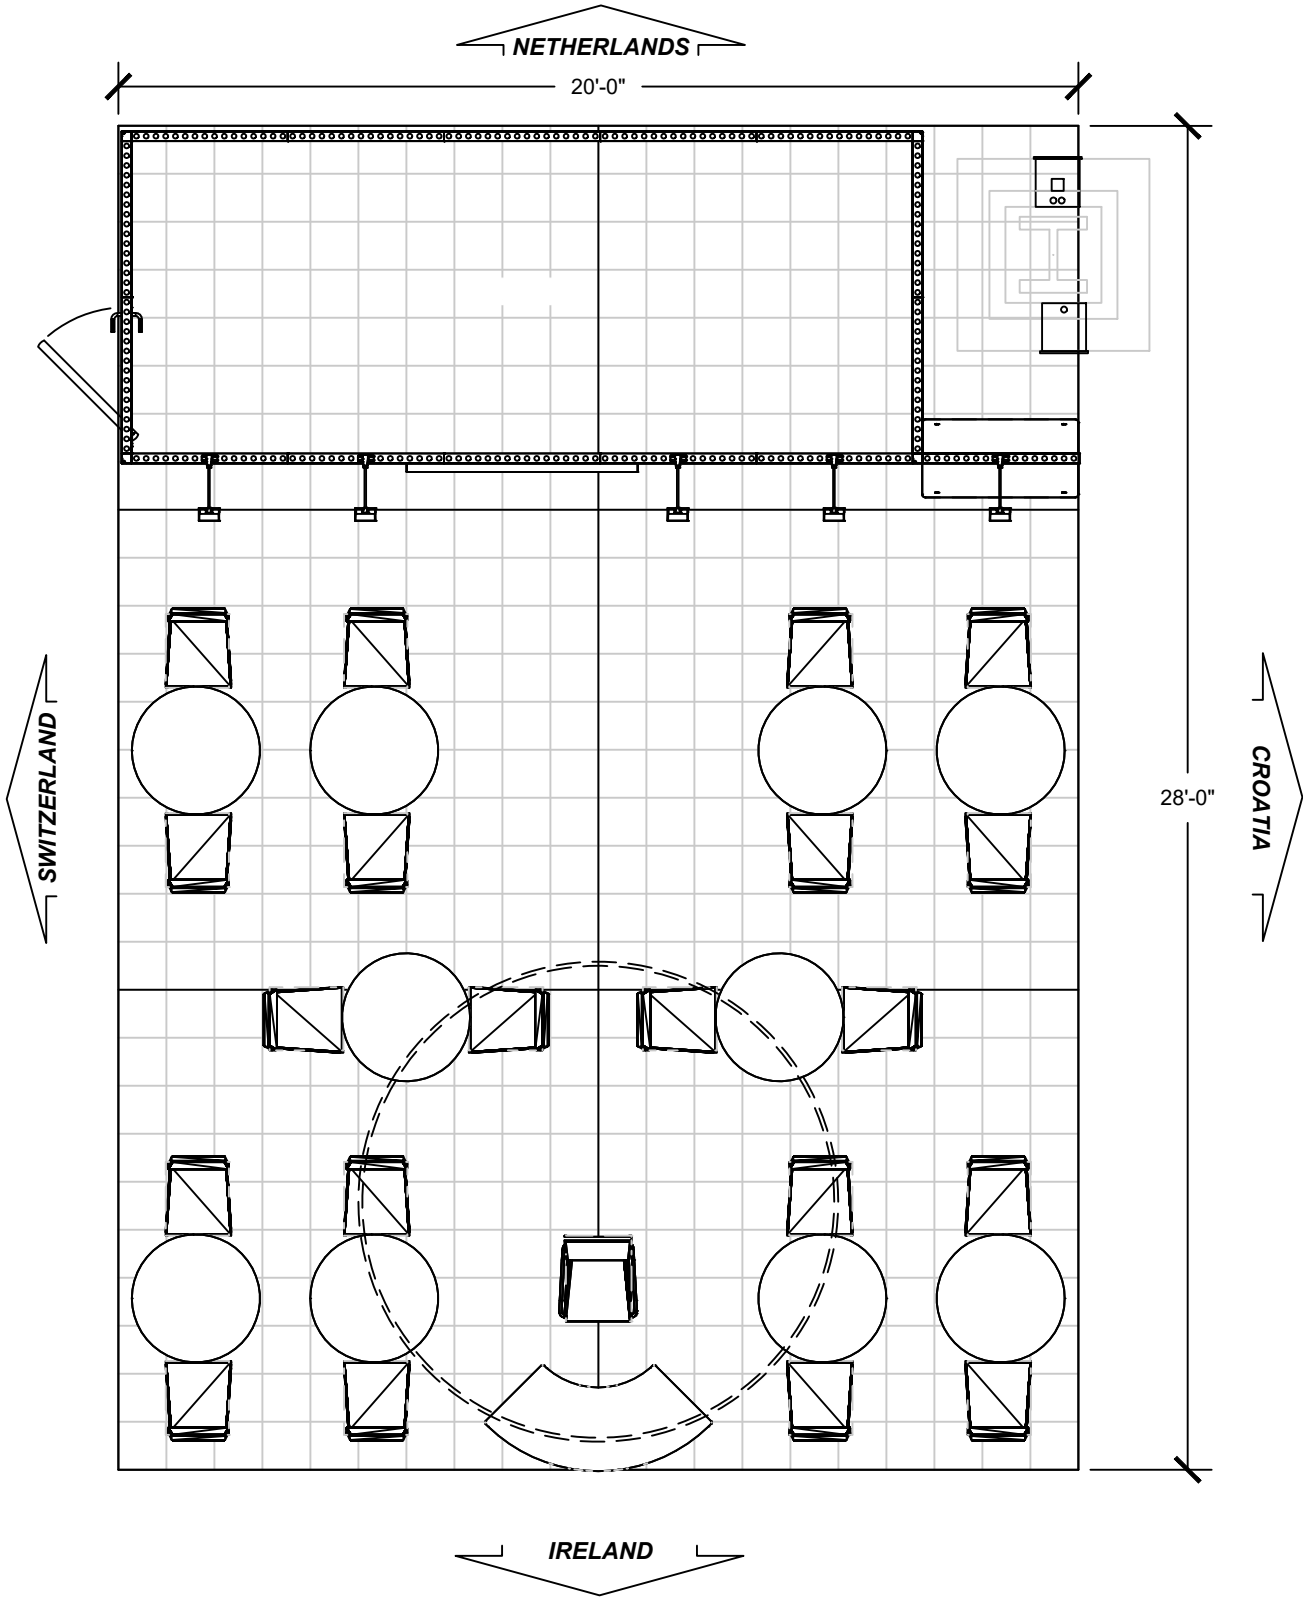


PLAN VIEW - ELECTRICAL

SCALE: 1/4" = 1'-0"

 
- ELECTRICAL LEGEND**
-  = MAIN POWER
 -  = POWER OUTLET
 -  = TELEPHONE OUTLET
 -  = INTERNET OUTLET
 -  = SPOTLIGHT
 -  = POWER LINE UNDER CARPET
 -  = POWER LINE OVER CARPET
 -  = GRID IS 12" x 12"

 Part of the SES Collective										CLIENT: CZECH TOURISM SHOW: IMEX 2024 FACILITY: MANDALAY BAY CONVENTION CENTER CITY/STATE: LAS VEGAS, NV										SHOW DATE: 10/09/24 - 10/10/24 PROJ. #: 11-826658 BOOTH NO: E1623 BOOTH SIZE: 20' X 28' SHIP DATE: ----										TITLE: ELECTRICAL SCALE: AS NOTED DRAWING DATE: 06/06/24 DRAWN BY: K SCHULTZ DWG LOCATION: SHAREPOINT										SHEET #: 03 OF 10 CONTACT INFORMATION AE: GAYMARIE BARRY (708) 203-9714 AM: CLAUDIA LANCE (508) 408-2162 PM: ----										DETAILING REVISION <table><thead><tr><th>No.</th><th>DATE</th><th>BY</th><th>DESCRIPTION</th></tr></thead><tbody><tr><td> </td><td> </td><td> </td><td> </td></tr><tr><td> </td><td> </td><td> </td><td> </td></tr><tr><td> </td><td> </td><td> </td><td> </td></tr></tbody></table> DWG LOCATION: SHAREPOINT										No.	DATE	BY	DESCRIPTION													Copyright © 2024 Sprocket, a division of SES. All rights reserved. No Part of this document may be reproduced, stored in a retrieval system, or transmitted in any form or by any means - electronic, mechanical, photocopying, recording or otherwise - without the express written consent of Sprocket, a division of SES.									
No.	DATE	BY	DESCRIPTION																																																																																		

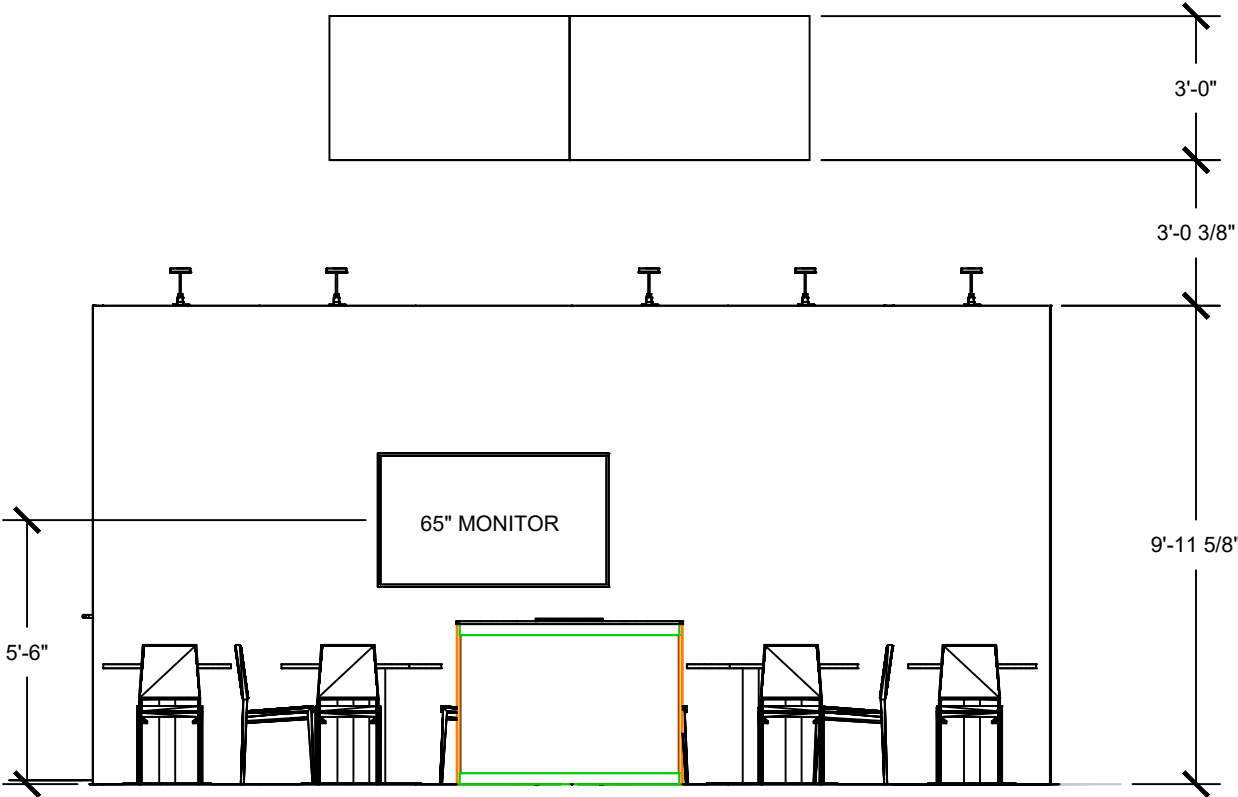

ELEVATION VIEW "A"

SCALE: 1/4" = 1'-0"

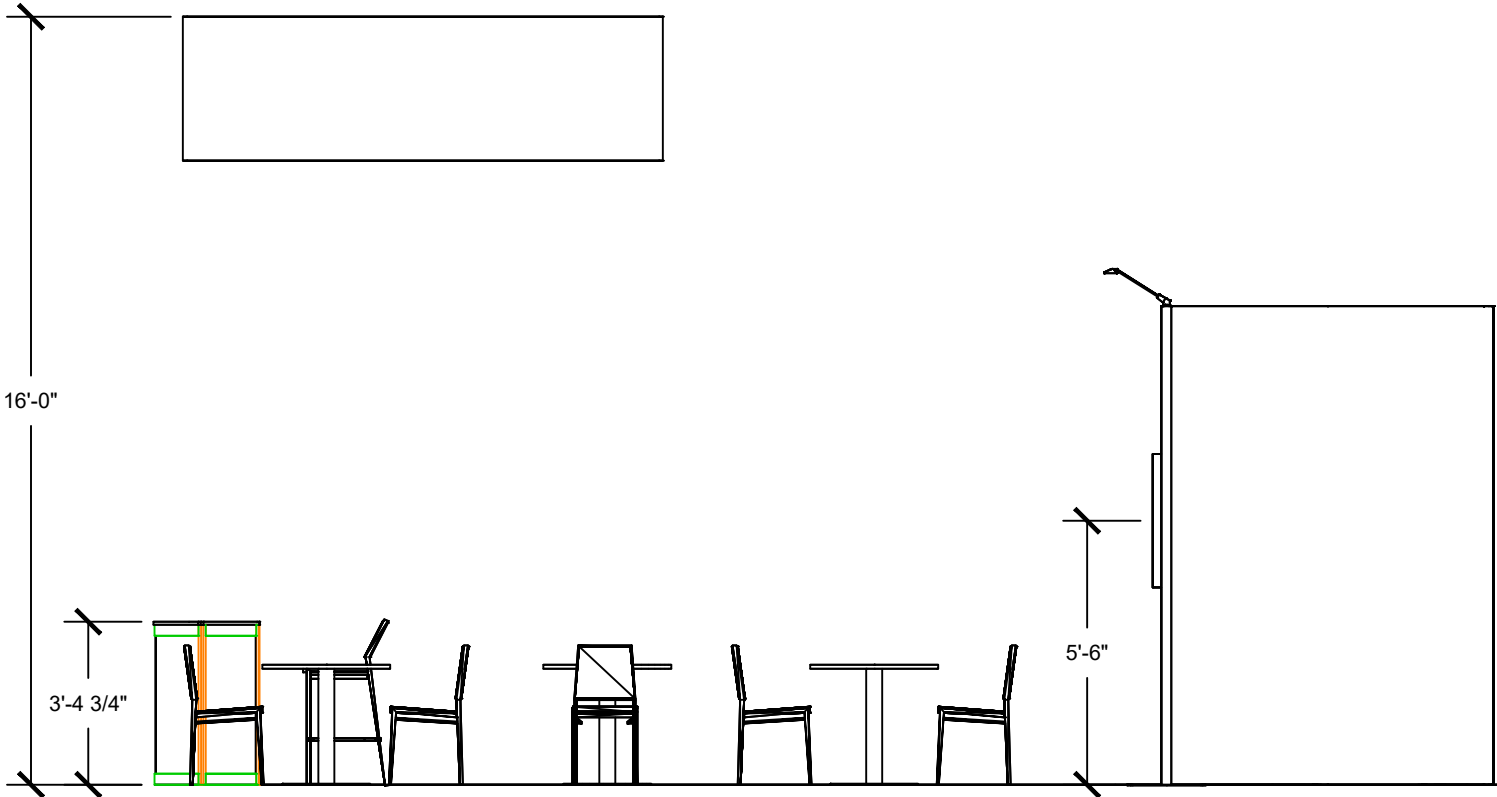

ELEVATION VIEW "B"

SCALE: 1/4" = 1'-0"



Part of the **GES** Collective

CLIENT:
CZECH TOURISM

SHOW:
IMEX 2024

FACILITY:
MANDALAY BAY CONVENTION CENTER

CITY/STATE:
LAS VEGAS, NV

SHOW DATE: 10/08/24 - 10/10/24

PROJ. #:
11-826658

BOOTH NO:
E1623

BOOTH SIZE:
20' X 28'

SHIP DATE:

TITLE:
ELEVATIONS

SCALE:
AS NOTED

DRAWING DATE:
06/06/24

DRAWN BY:
K SCHULTZ

DWG LOCATION:
SHAREPOINT

SHEET #:
04

OF
10

CONTACT INFORMATION
AE: GAYMARIE BARRY (708) 203-9714
AM: CLAUDIA LANCE (508) 408-2162
PM: ----


DETAILING REVISION

No.	DATE	BY	DESCRIPTION
DWG LOCATION: SHAREPOINT			

Copyright © 2024, Spiro, a division of GES. All rights reserved. No part of this document may be reproduced, stored in a retrieval system, or transmitted in any form or by any means - electronic, mechanical, photocopying, recording or otherwise - without the express written consent of Spiro, a division of GES.

PLAN VIEW - HANGING SIGN

SCALE: 1/4" = 1'-0"

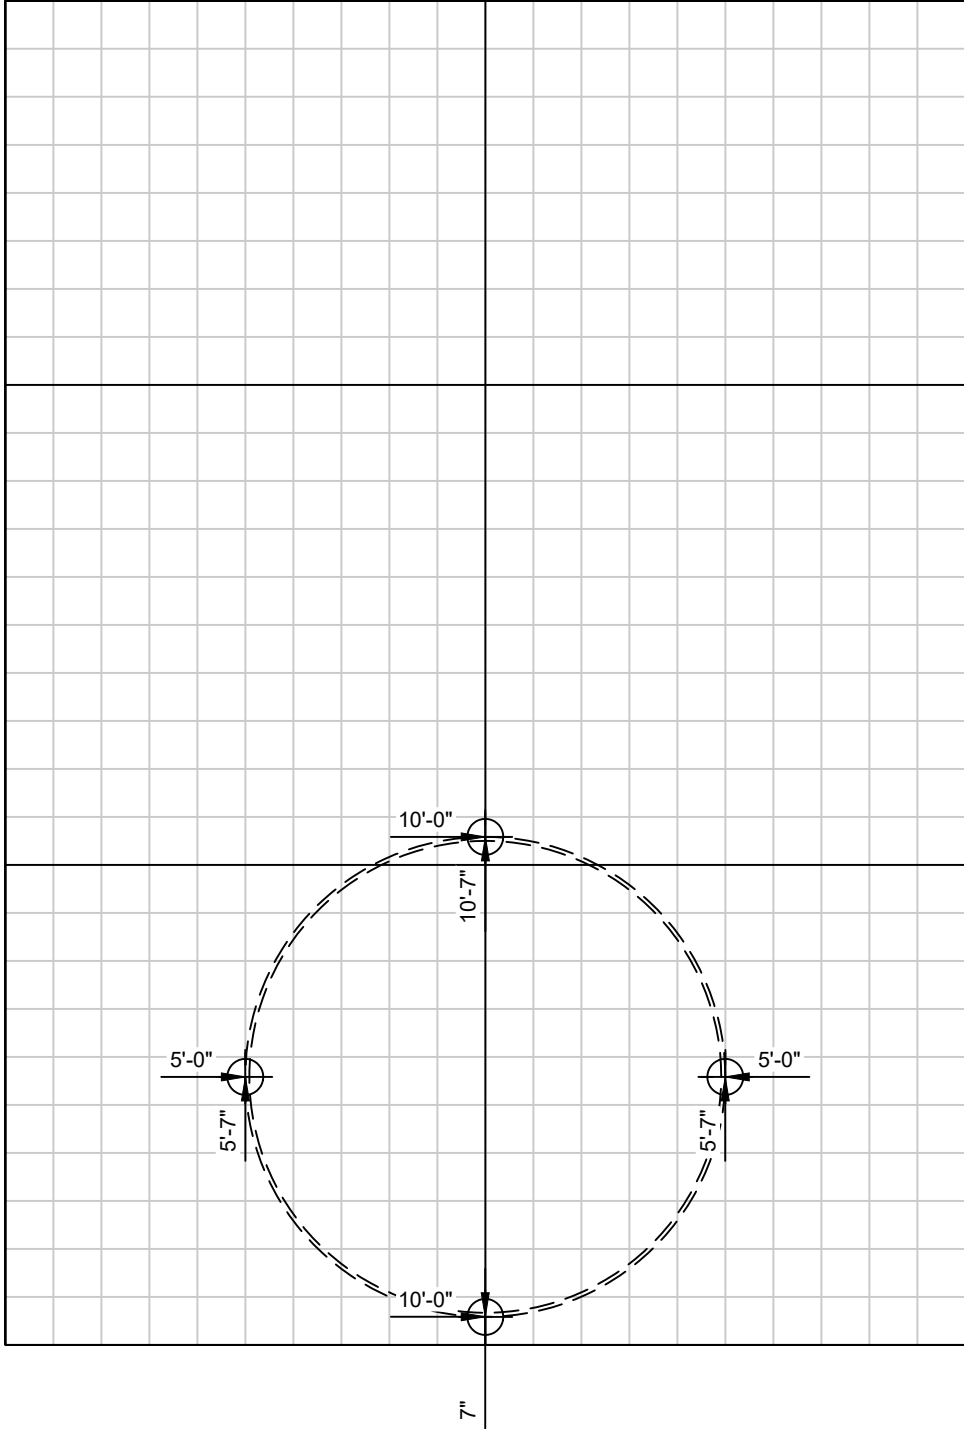

CLIENT:
CZECH TOURISM

SHOW:
IMEX 2024

FACILITY:
MANDALAY BAY CONVENTION CENTER

CITY/STATE:
LAS VEGAS, NV

FILE NAME: SharePoint\Clients\Czech Tourism\2024\IMEX 2024_11-826658_17x30\Detailing\11-826658_Czech Tourism_IMEX 2024_v02.dwg

SHOW DATE: 10/08/24 - 10/10/24

PROJ. #:
11-826658

BOOTH NO:
E1623

BOOTH SIZE:
20' X 28'

SHIP DATE:

TITLE:
HANGING SIGN

SCALE:
AS NOTED

DRAWING DATE:
06/06/24

DRAWN BY:
K SCHULTZ

DWG LOCATION:
SHAREPOINT

SHEET #:
05

OF
10

CONTACT INFORMATION

AE: GAYMARIE BARRY (708) 203-9714

AM: CLAUDIA LANCE (508) 408-2162

PM: ----

DETAILING REVISION

No. DATE BY DESCRIPTION

DWG LOCATION: SHAREPOINT

Copyright © 2024, Spiro, a division of GES. All rights reserved. No part of this document may be reproduced, stored in any retrieval system, or transmitted in any form or by any means - electronic, mechanical, photocopying, recording or otherwise - without the express written consent of Spiro, a division of GES.

QTY	CATEGORY	PART NUMBER	DESCRIPTION	COLOR	MATERIAL	LENGTH	HEIGHT	THICK	NOTES
1	SEG/FABRIC	A1	SEG FABRIC	N/A	FABRIC	83"	119 5/8"	N/A	W/ DOOR PANEL
1	SEG/FABRIC	A2	SEG FABRIC	N/A	FABRIC	239 3/16"	119 5/8"	N/A	
1	SEG/FABRIC	A3	SEG FABRIC	WHITE	FABRIC	39 1/8"	119 5/8"	N/A	
1	SEG/FABRIC	A4	SEG FABRIC	WHITE	FABRIC	80 9/16"	119 5/8"	N/A	
1	SEG/FABRIC	A5	SEG FABRIC	WHITE	FABRIC	200 1/16"	119 5/8"	N/A	
1	OVERLAY	S1	OVERLAY, VELCRO	WHITE	SINTRA	2 7/16"	119 5/8"	1/8"	OVERLAY



DETAILING REVISION			
No.	DATE	BY	DESCRIPTION
DWG LOCATION: SHAREPOINT			

Copyright © 2024 Sprio, a division of GES. All rights Reserved. No Part of this document may be reproduced without any written permission, or translation in any form or by any means, electronic or mechanical, including photocopying, recording, or by any information storage and retrieval system, without the express written consent of Sprio, a division of GES.

SHEET #: 06 OF 10	CONTACT INFORMATION
	AE: GAYMARIE BARRY (708) 203-9714
	AM: CLAUDIA LANCE (508) 408-2162
	PM: ----

SHOW DATE: 10/08/24 - 10/10/24	TITLE: STORAGE
PROJ. #: 11-826658	SCALE: AS NOTED
BOOTH NO: E1623	DRAWING DATE: 06/06/24
BOOTH SIZE: 20' X 28'	DRAWN BY: K SCHULTZ
SHIP DATE: DATE	DWG LOCATION: SHAREPOINT


CLIENT: **CZECH TOURISM**
SHOW: IMEX 2024
FACILITY: MANDALAY BAY CONVENTION CENTER
CITY/STATE: LAS VEGAS, NV



AMP BOM - STORAGE

Count	CATEGORY	DESCRIPTION	DIMENSIONS	NOTES
15	01.1-FRAME_RENTAL	0992 x 0620 mm Flat SEG Frame	39.06" x 24.41"	
14	01.1-FRAME_RENTAL	0992 x 2418 mm Flat SEG Frame	39.06" x 95.20"	
1	01.2-FRAME_RENTAL	0992 x 2418 mm ECO Door SEG Frame	39.06" x 95.20"	
4	02.1-POST_RENTAL	0620 mm H 90 SEG Corner Post	24.41" Corner Post	
4	02.1-POST_RENTAL	2418 mm H 90 SEG Corner Post	95.20" Corner Post	
5	03-HARDWARE_RENTAL	D30 Frame to Door Connector	6.00" x 1.375"	
66	03-HARDWARE_RENTAL	D30 Frame to Frame Connector	6.75" x 1.375"	
3	03-HARDWARE_RENTAL	M8 Threaded Door to Corner Post Connector	3.39" Total Length	
34	03-HARDWARE_RENTAL	M8 Threaded Frame to Corner Post Connector	4.31" Total Length	
1	04-BASEPLATE_RENTAL	0992 x 0496 mm Base Plate Each Includes: (1) Base Plate, (2) M8 Threaded Pin Connectors, & (2) D30 Single Pins	39.06" x 19.52"	Connectors included w/ base plate are separate from any other connectors listed in the B.O.M.
2	05.1-ACCESSORY_RENTAL	M8 Threaded Pin for D30 Custom Connector	N/A	
1	05.2-ACCESSORY_RENTAL	39W Support Set, Full: Each Includes (4) Brackets & (1) Full Plywood Support Panel	33.125" x 87.00"	Panel and brackets to be reserved in Trace
5	05-ACCESSORY	STEM LIGHT		
13	06.1-INSERT	39 x 95 FRAME INSERT	38 3/4" x 94 15/16"	1/8" WHITE SINTRA
1	06.2-INSERT	39 x 95 DOOR INSERT SET 4-PIECES PER SET	FRAME: (2) pcs. 2 3/8" x 94 5/8" (1) pc. 2 3/8" x 34 1/16" LEAF: 33 1/16" x 90 13/16"	1/8" WHITE SINTRA

NOTE: LOWER FRAMES FOR STORAGE ROOM HAVE SINTRA INSERT

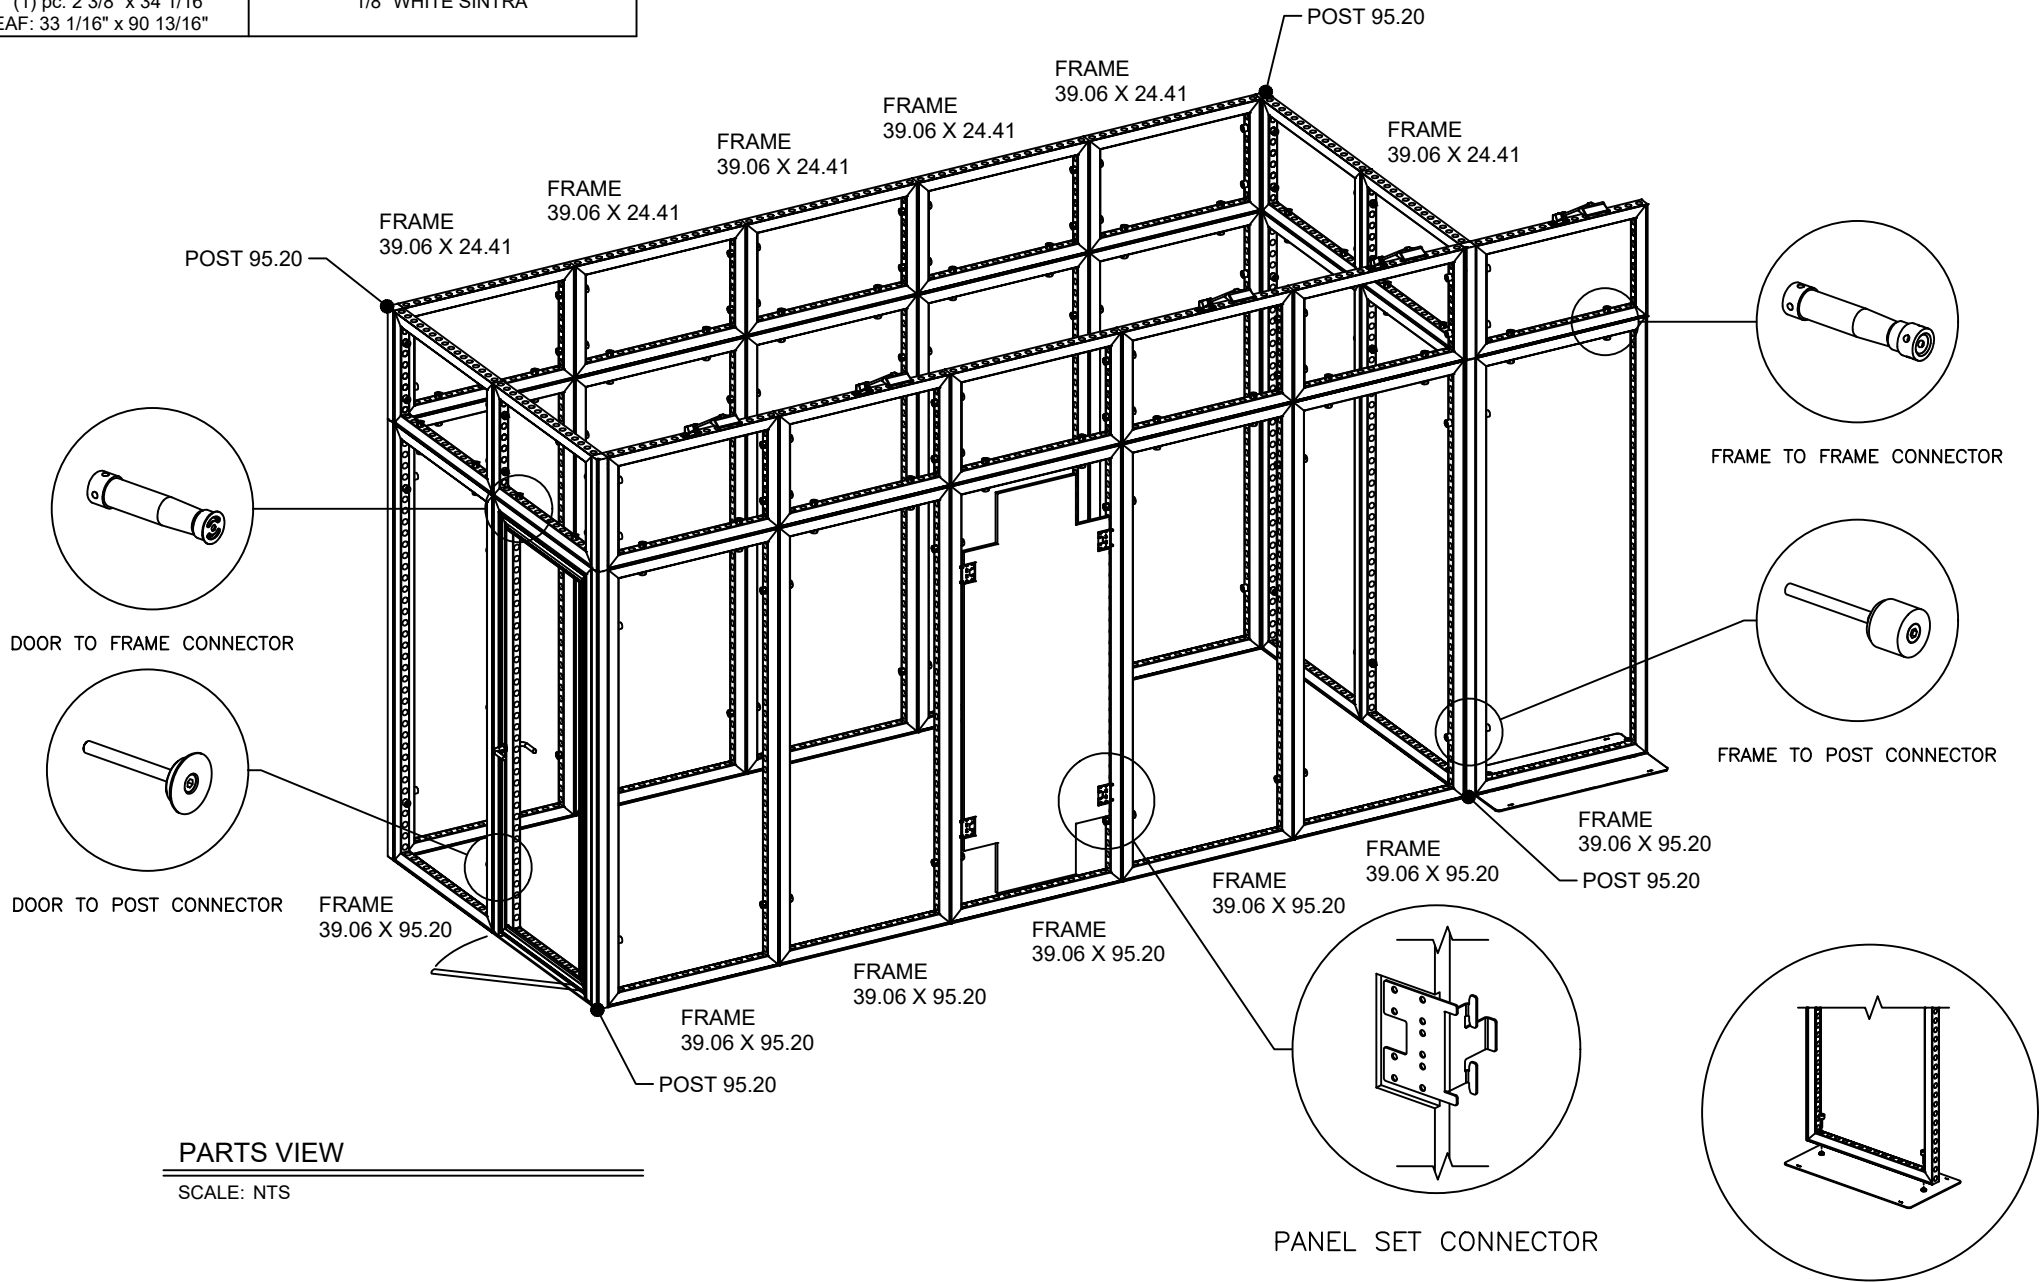

DETAILING REVISION

No.	DATE	BY	DESCRIPTION

CONTACT INFORMATION

AE: GAYMARIE BARRY (708) 203-9714
AM: CLAUDIA LANCE (508) 408-2162
PM: ---

HARDWARE

TITLE: AS NOTED
SCALE: DRAWING DATE: 06/06/24
DRAWN BY: K SCHULTZ
DWG LOCATION: SHAREPOINT

SHOW DATE: 10/08/24 - 10/10/24
PROJ. #: 11-826658
BOOTH NO: E1623
BOOTH SIZE: 20' X 28'
SHIP DATE: ---


CLIENT: CZECH TOURISM
SHOW: IMEX 2024
FACILITY: MANDALAY BAY CONVENTION CENTER
CITY/STATE: LAS VEGAS, NV

FILE NAME: SharePoint\Clients\Czech Tourism\2024\IMEX 2024_11-826658_17x30\Detailing\11-826658_Czech Tourism_IMEX 2024_v02.dwg




Part of the GES Collective

Copyright © 2024, Spiral, a division of GES. All rights reserved. No part of this document may be reproduced, stored in any retrieval system, or transmitted in any form or by any means - electronic, mechanical, photocopying, recording or otherwise - without the express written consent of Spiral, a division of GES.

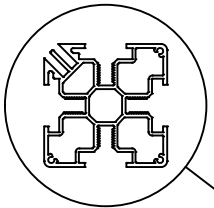



ELEVATION VIEW "A"

SCALE: 3/8" = 1'-0"

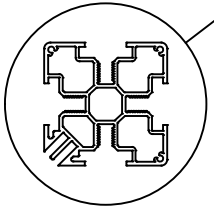


PLAN VIEW - METAL

SCALE: 3/8" = 1'-0"

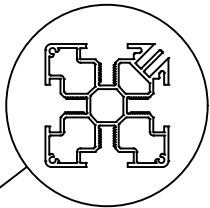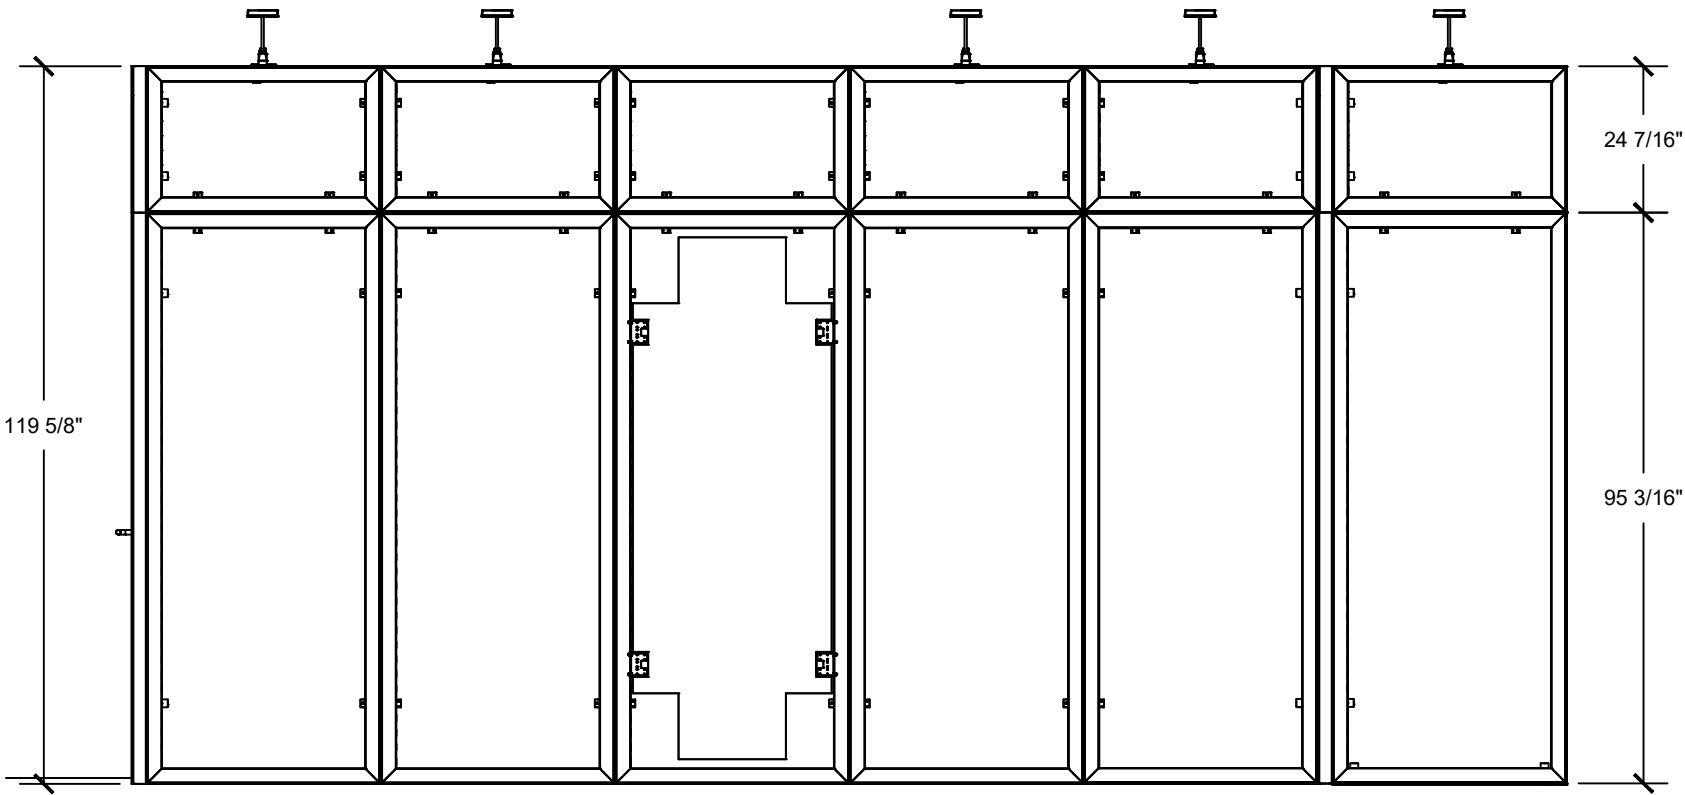

ELEVATION VIEW "B"

SCALE: 3/8" = 1'-0"

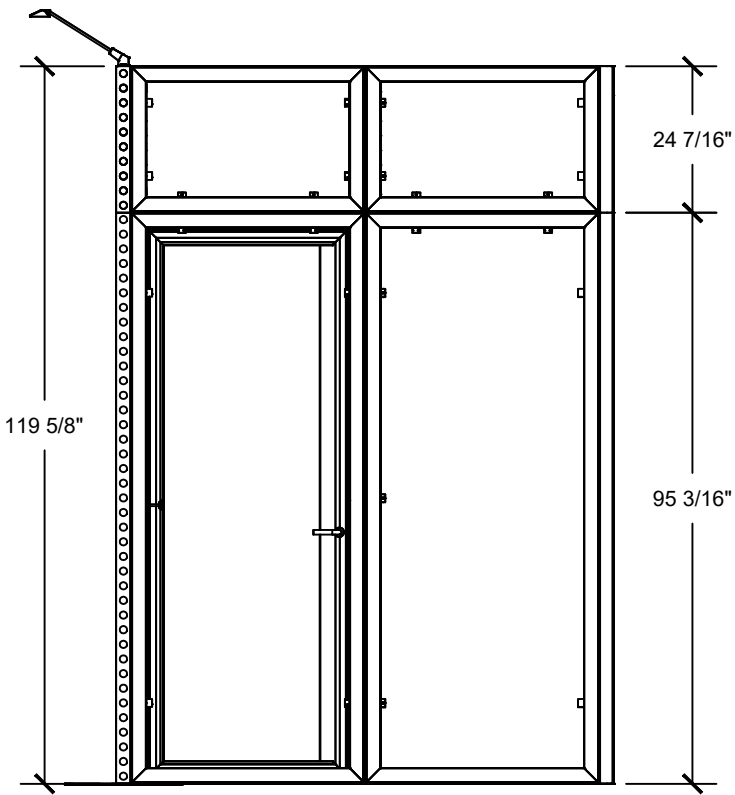



Part of the **GES** Collective

CLIENT:
CZECH TOURISM

SHOW:
IMEX 2024

FACILITY:
MANDALAY BAY CONVENTION CENTER

CITY/STATE:
LAS VEGAS, NV

SHOW DATE: 10/08/24 - 10/10/24

PROJ. #: 11-826658

BOOTH NO: E1623

BOOTH SIZE: 20' X 28'

SHIP DATE: ---

TITLE:
DETAILS

SCALE:
AS NOTED

DRAWING DATE: 06/06/24

DRAWN BY:
K SCHULTZ

DWG LOCATION: SHAREPOINT


SHEET #: 08 OF 10

CONTACT INFORMATION
AE: GAYMARIE BARRY (708) 203-9714
AM: CLAUDIA LANCE (508) 408-2162
PM: ---

DETAILING REVISION


No.	DATE	BY	DESCRIPTION
DWG LOCATION: SHAREPOINT			

Copyright © 2024, Spiral, a division of GES. All rights reserved. No part of this document may be reproduced, stored in a retrieval system, or transmitted in any form or by any means - electronic, mechanical, photocopying, recording or otherwise - without the express written consent of Spiral, a division of GES.

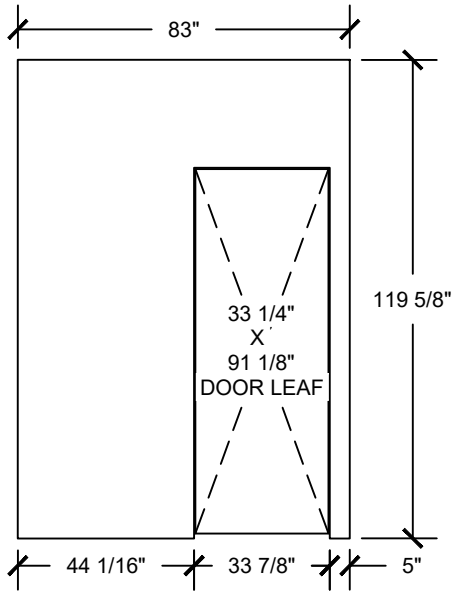


FLAT VIEW - FABRIC "A1"

SCALE: 3/8" = 1'-0"

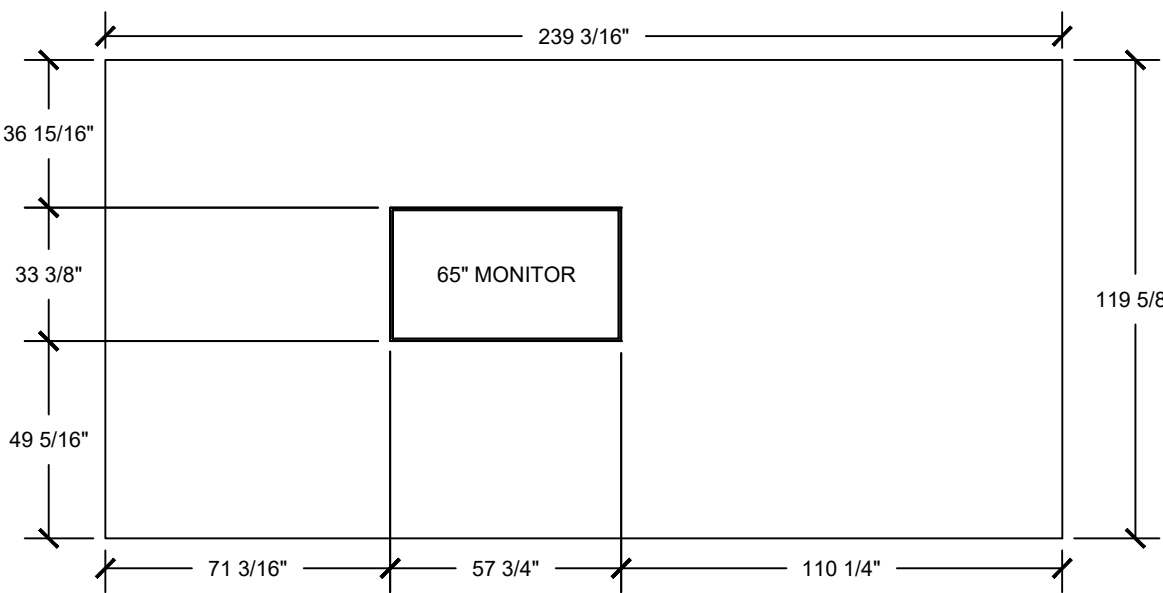

FLAT VIEW - FABRIC "A2"


SCALE: 3/8" = 1'-0"

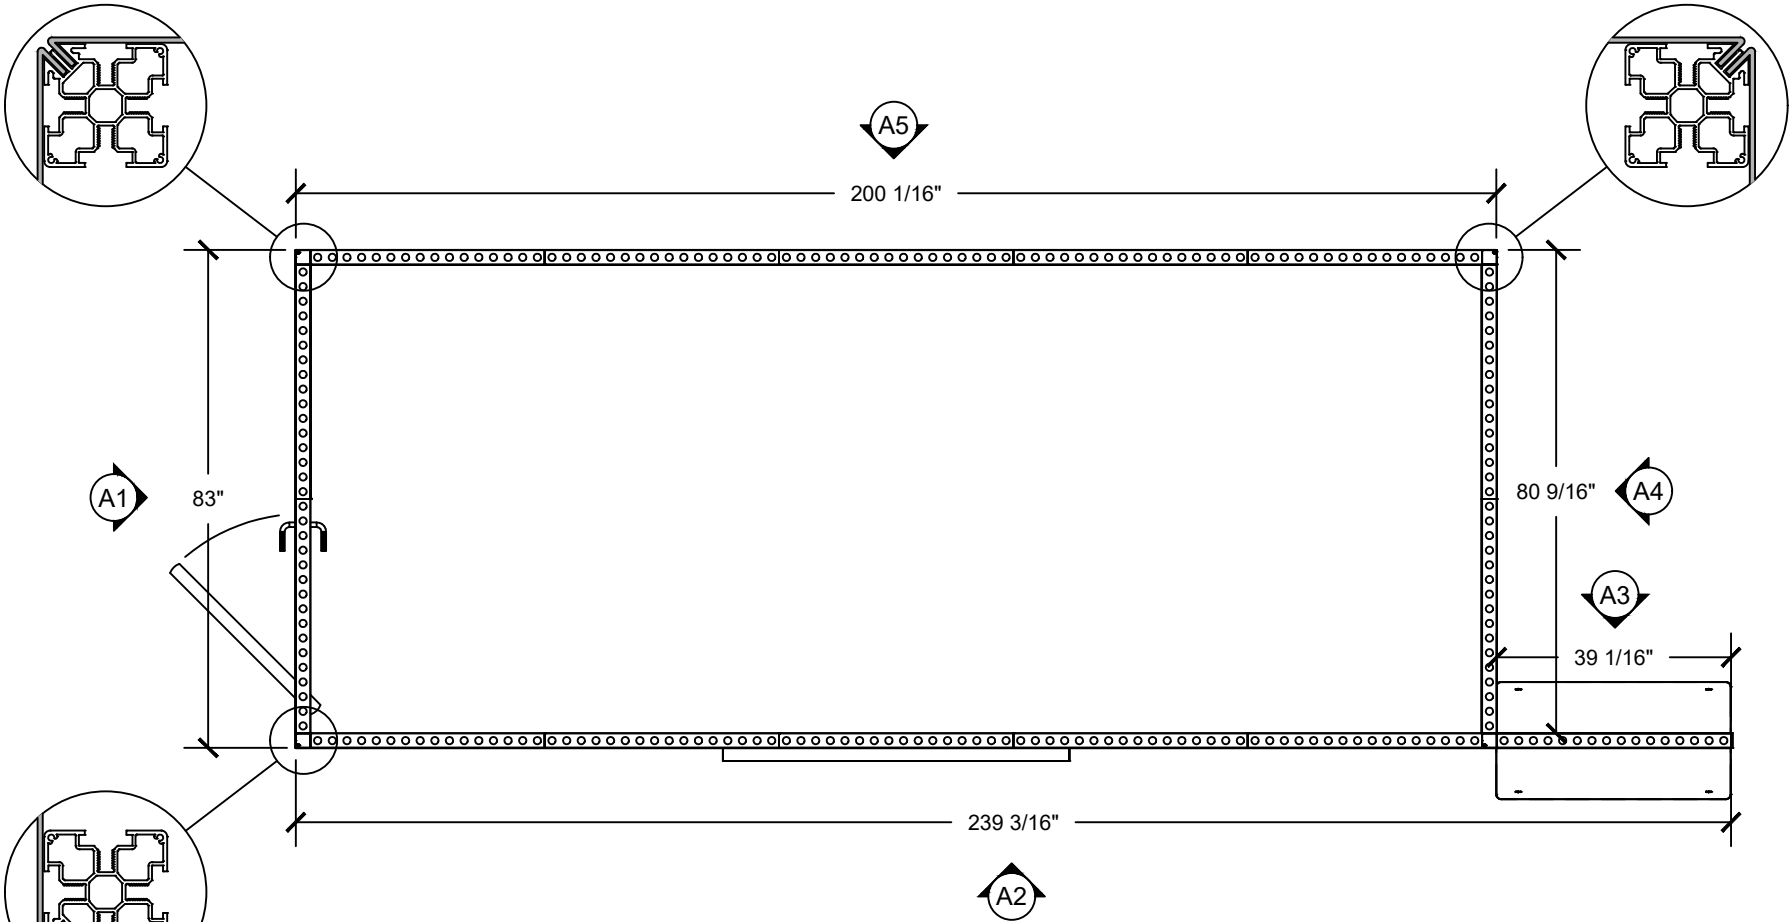

PLAN VIEW - FABRIC


SCALE: 3/8" = 1'-0"

 Part of the GES Collective	CLIENT: CZECH TOURISM			SHOW DATE: 10/08/24 - 10/10/24			TITLE: FABRIC			SHEET #: 09 OF 10		
	SHOW: IMEX 2024			PROJ. #: 11-826658			SCALE: AS NOTED			CONTACT INFORMATION AE: GAYMARIE BARRY (708) 203-9714 AM: CLAUDIA LANCE (508) 408-2162 PM: ----		
	FACILITY: MANDALAY BAY CONVENTION CENTER			BOOTH NO: E1623			DRAWING DATE: 06/06/24					
	CITY/STATE: LAS VEGAS, NV			BOOTH SIZE: 20' X 28'			DRAWN BY: K SCHULTZ					
			SHIP DATE: ----			DWG LOCATION: SHAREPOINT						
FILE NAME: SharePoint\Clients\Czech Tourism\2024\IMEX 2024_11-826658_17x30\Detailing\11-826658_Czech Tourism_IMEX 2024_v02.dwg												
Copyright © 2024 Spira, a division of GES. All rights Reserved. No Part of this document may be reproduced, stored in any retrieval system, or transmitted in any form or by any means - electronic, mechanical, photocopying, recording or otherwise - without the express written consent of Spira, a division of GES.												

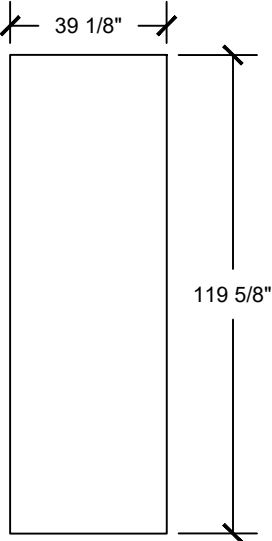


FLAT VIEW - FABRIC "A3"

SCALE: 3/8" = 1'-0"

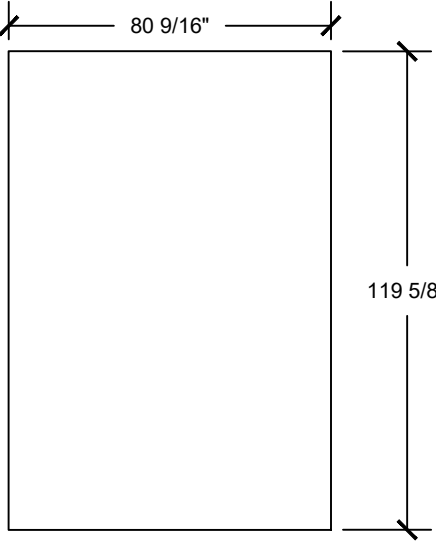

FLAT VIEW - FABRIC "A4"

SCALE: 3/8" = 1'-0"

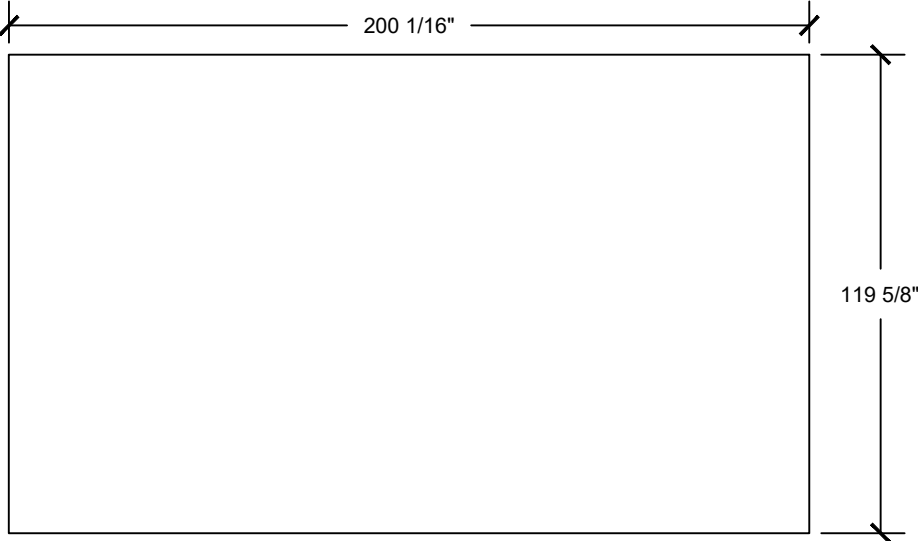

FLAT VIEW - FABRIC "A5"

SCALE: 3/8" = 1'-0"



CLIENT: CZECH TOURISM
SHOW: IMEX 2024
FACILITY: MANDALAY BAY CONVENTION CENTER
CITY/STATE: LAS VEGAS, NV

SHOW DATE: 10/08/24 - 10/10/24
PROJ. #: 11-826658
BOOTH NO: E1623
BOOTH SIZE: 20' X 28'
SHIP DATE: ---

TITLE: FABRIC
SCALE: AS NOTED
DRAWING DATE: 06/06/24
DRAWN BY: K SCHULTZ
DWG LOCATION: SHAREPOINT

SHEET #: 10 OF 10
CONTACT INFORMATION
AE: GAYMARIE BARRY (708) 203-9714
AM: CLAUDIA LANCE (508) 408-2162
PM: ---

DETAILING REVISION				DESCRIPTION
No.	DATE	BY		
DWG LOCATION: SHAREPOINT				Copyright © 2024 Spirio, a division of GES. All rights reserved. No part of this document may be reproduced, stored in any retrieval system, or transmitted in any form or by any means - electronic, mechanical, photocopying, recording or otherwise - without the express written consent of Spirio, a division of GES.